


LEGEND - Existing Services

|          |       |             |             |             |
|----------|-------|-------------|-------------|-------------|
| GAS      | CURB  | SIDWALK     | SILT TRAP   | VALVE       |
| GAS      | DITCH | ST. LIGHT   | CONC. BOX   | FLUSH VALVE |
| GAS      | DRAIN | FIBER OPTIC | WOODBBOX    | HYDRANT     |
| GAS      | WATER | MANHOLE     | CATCH BASIN | REDUCER     |
| HYD./TEL | SEWER | CLEANOUT    | CAP         | PLUG        |

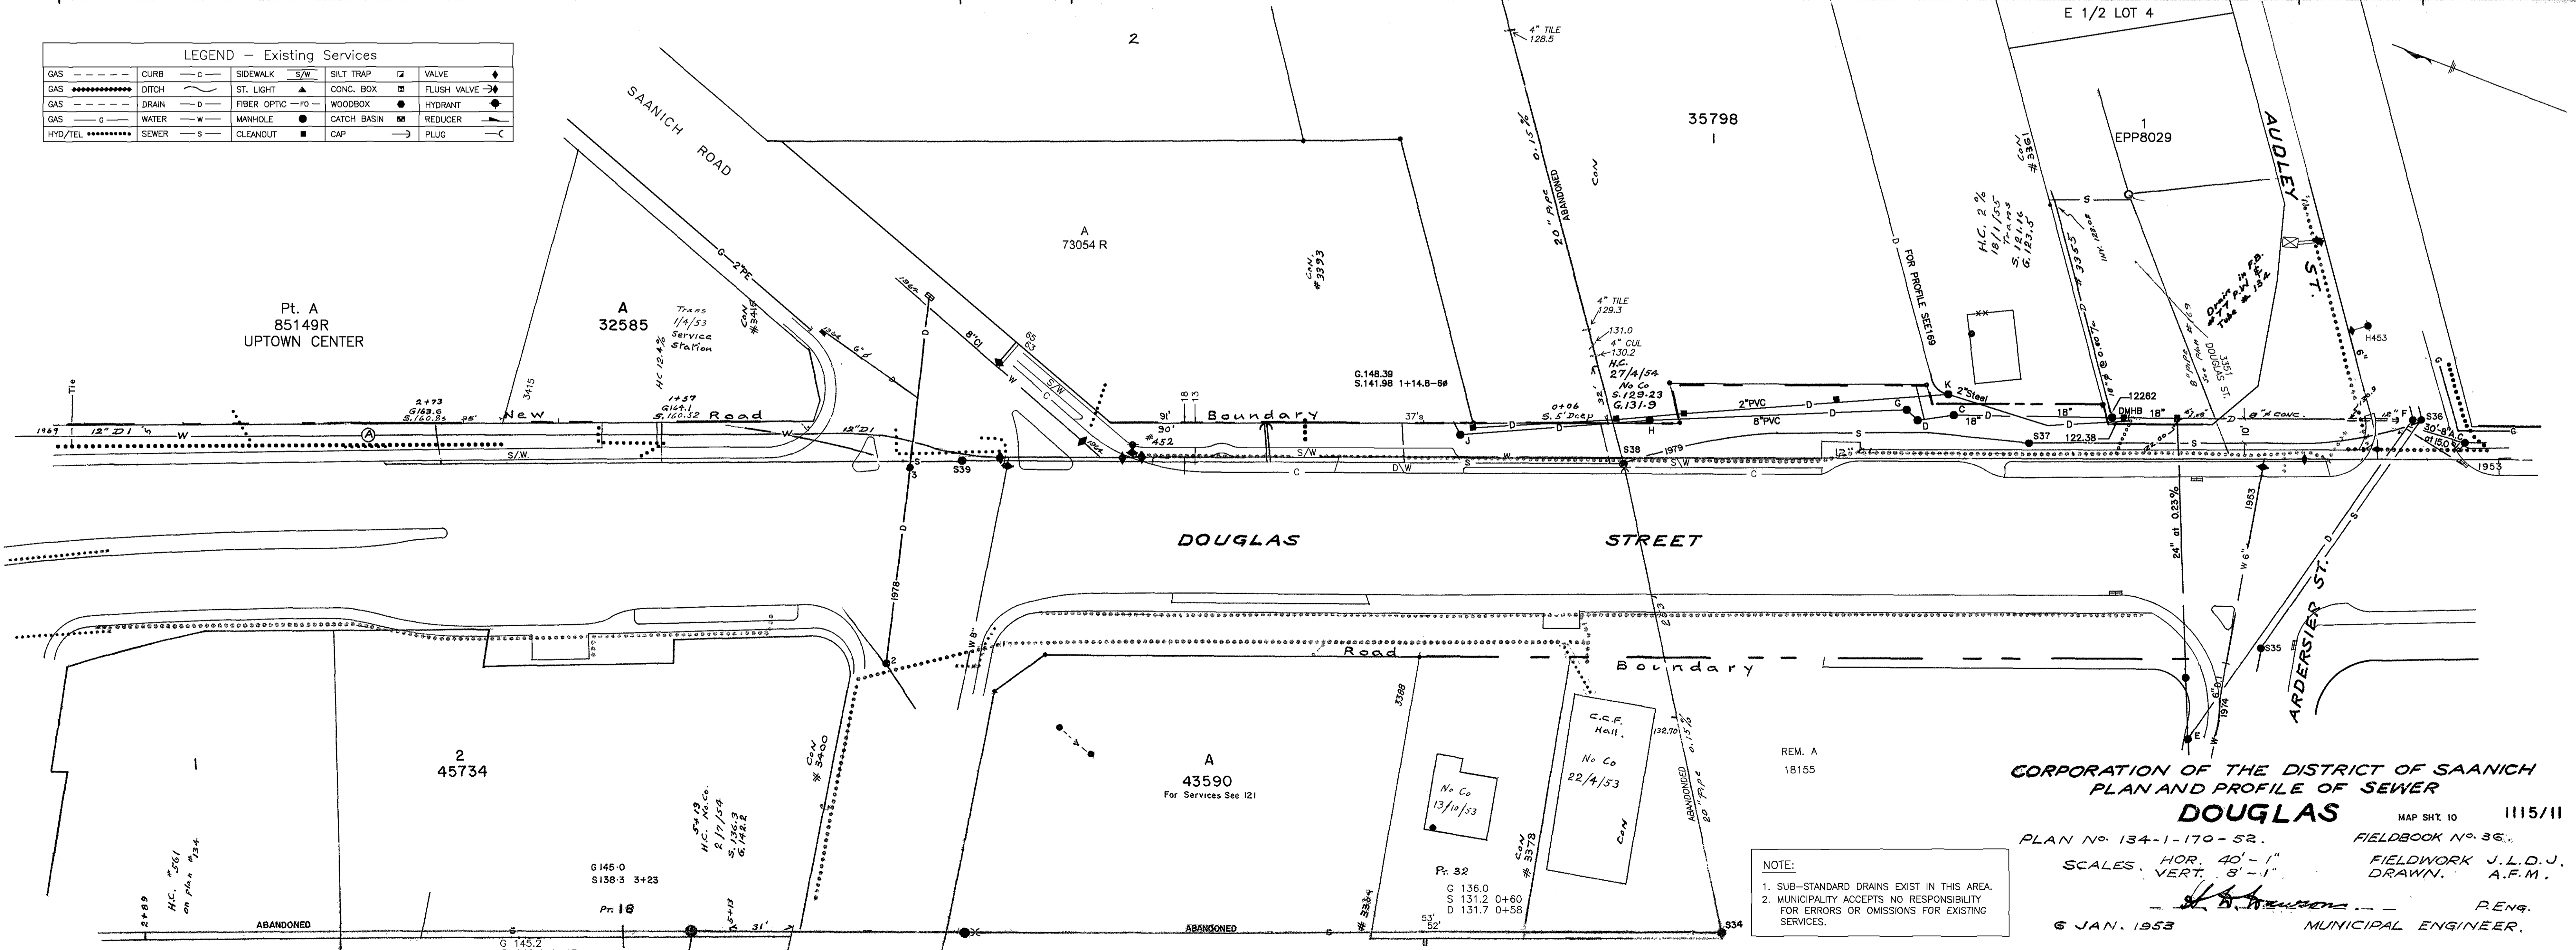

CORPORATION OF THE DISTRICT OF SAANICH  
 PLAN AND PROFILE OF SEWER  
**DOUGLAS**  
 MAP SHT. 10 1115/11  
 PLAN No. 134-1-170-52. FIELDBOOK No. 36.  
 SCALES: HOR. 40'-1" VERT. 8'-1"  
 FIELDWORK J.L.D.J. DRAWN. A.F.M.  
 6 JAN. 1953 MUNICIPAL ENGINEER.