


LEGEND - Existing Services

GAS	CURB	SIDWALK	SILT TRAP	VALVE
GAS	DITCH	ST. LIGHT	CONC. BOX	FLUSH VALVE
GAS	DRAIN	FIBER OPTIC	WOODBOX	HYDRANT
GAS	WATER	MANHOLE	CATCH BASIN	REDUCER
HYD./TEL	SEWER	CLEANOUT	CAP	PLUG

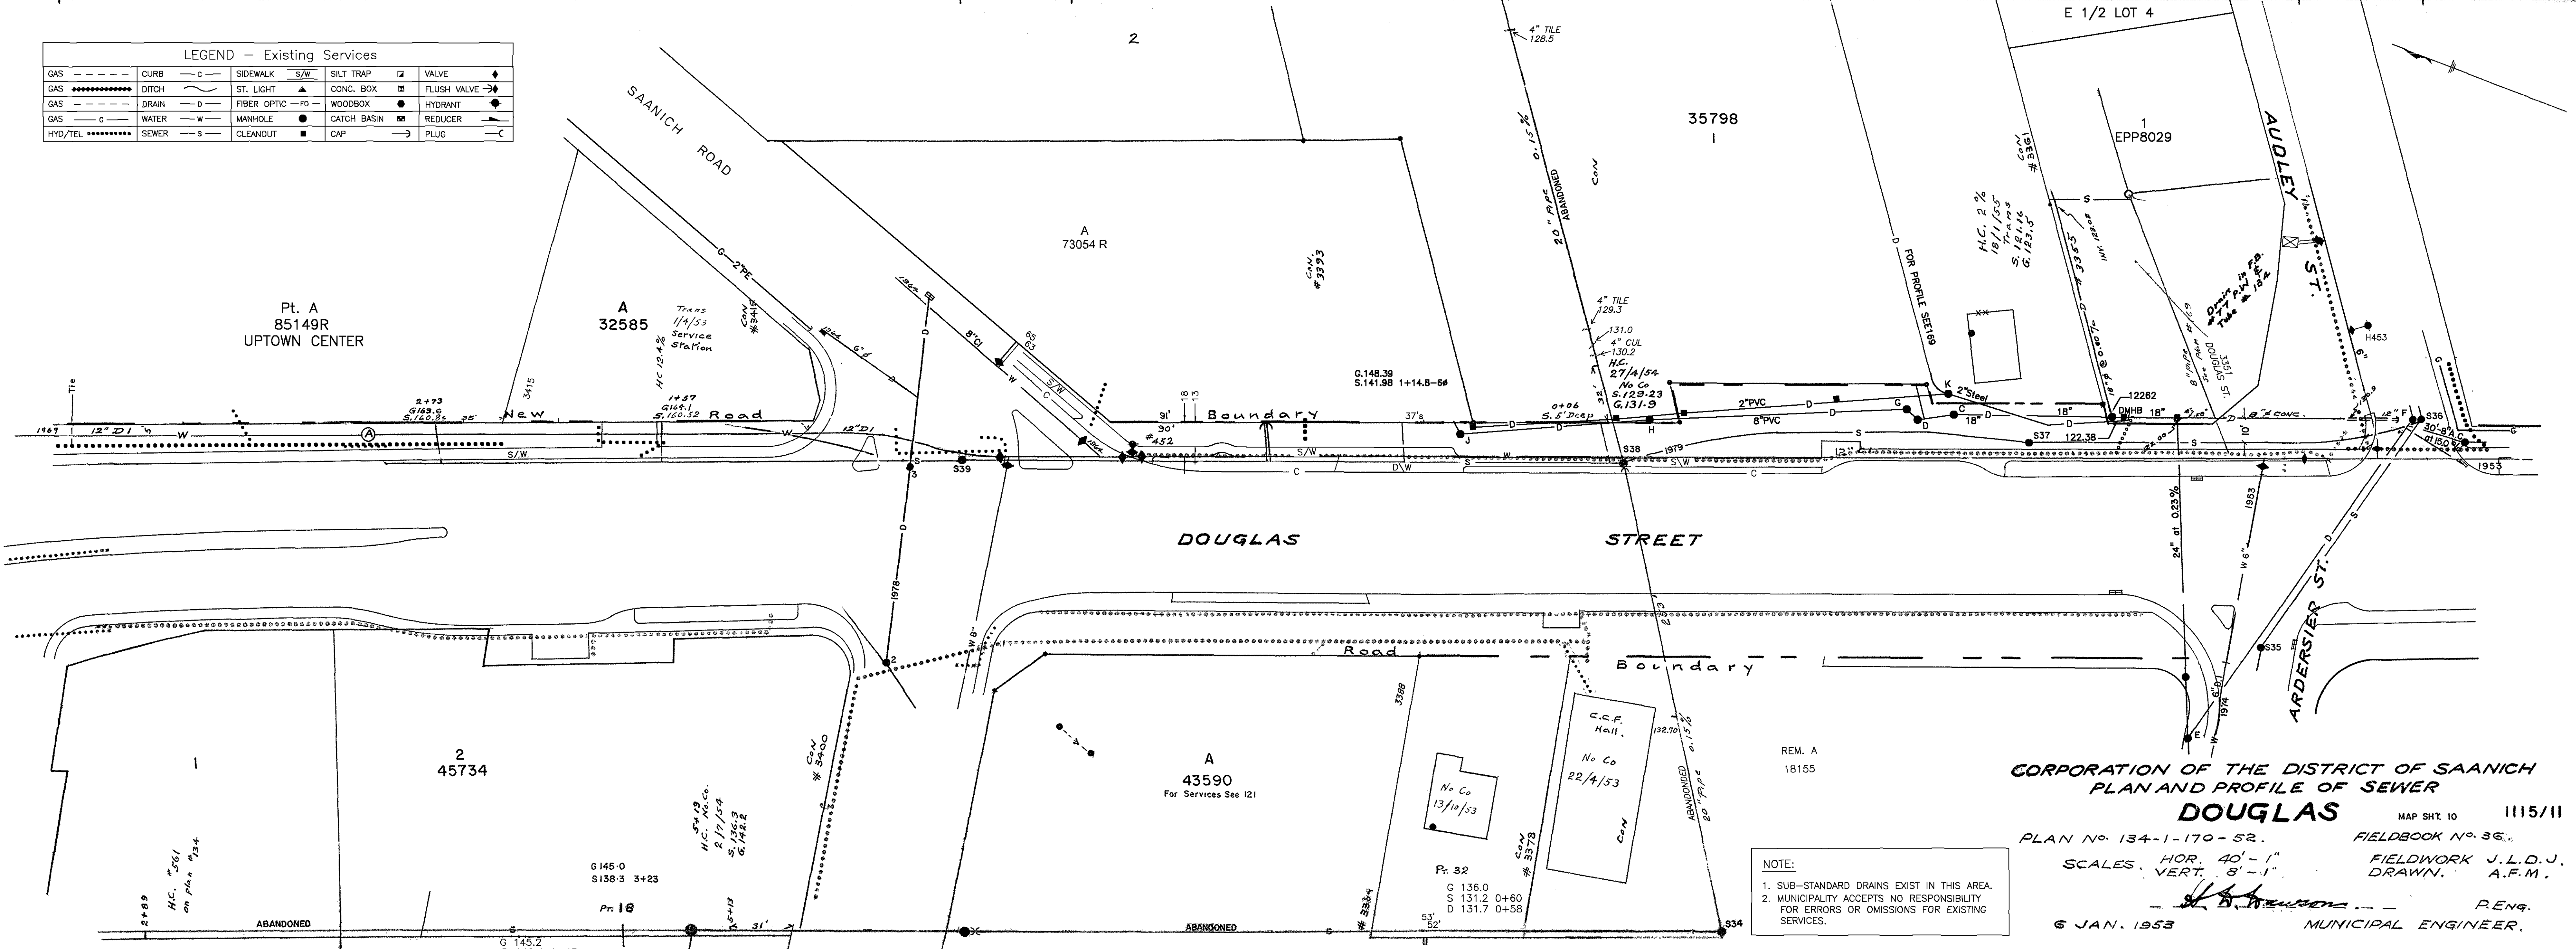

CORPORATION OF THE DISTRICT OF SAANICH
 PLAN AND PROFILE OF SEWER
DOUGLAS
 MAP SHT. 10 1115/11
 PLAN No. 134-1-170-52. FIELDBOOK No. 36.
 SCALES: HOR. 40'-1" VERT. 8'-1" FIELDWORK J.L.D.J. DRAWN. A.F.M.
 6 JAN. 1953 MUNICIPAL ENGINEER.