


SCALE: HORIZ 1:500  
VERT 1:500

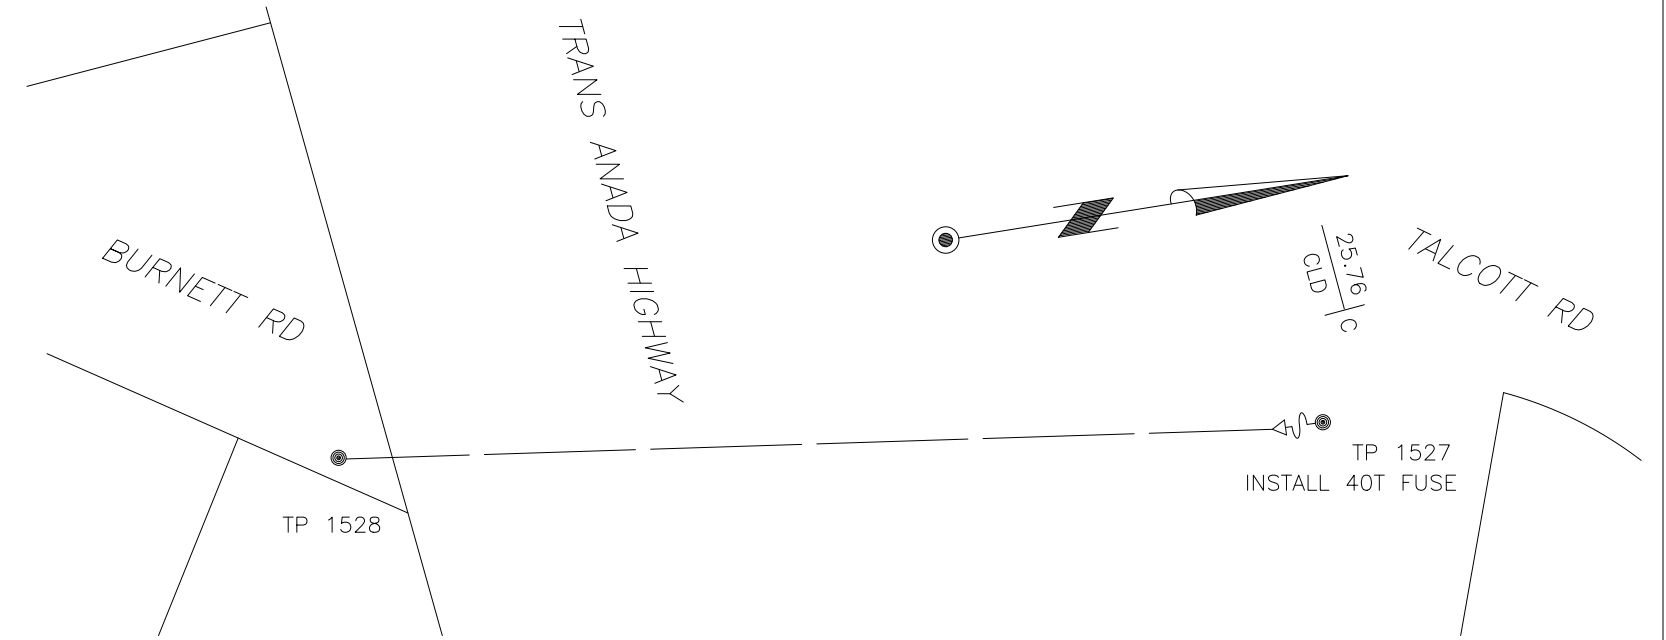

# ELECTRICAL


1:500

**ELECTRICAL LEGEND:**



1C #1AL 25kv CONCENTRIC NEUTRAL PRIMARY CABLE

**NOTES:**

1. Tag all primary feeds.
2. Install number decals on all primary installations and Terminal Pole cable cover.

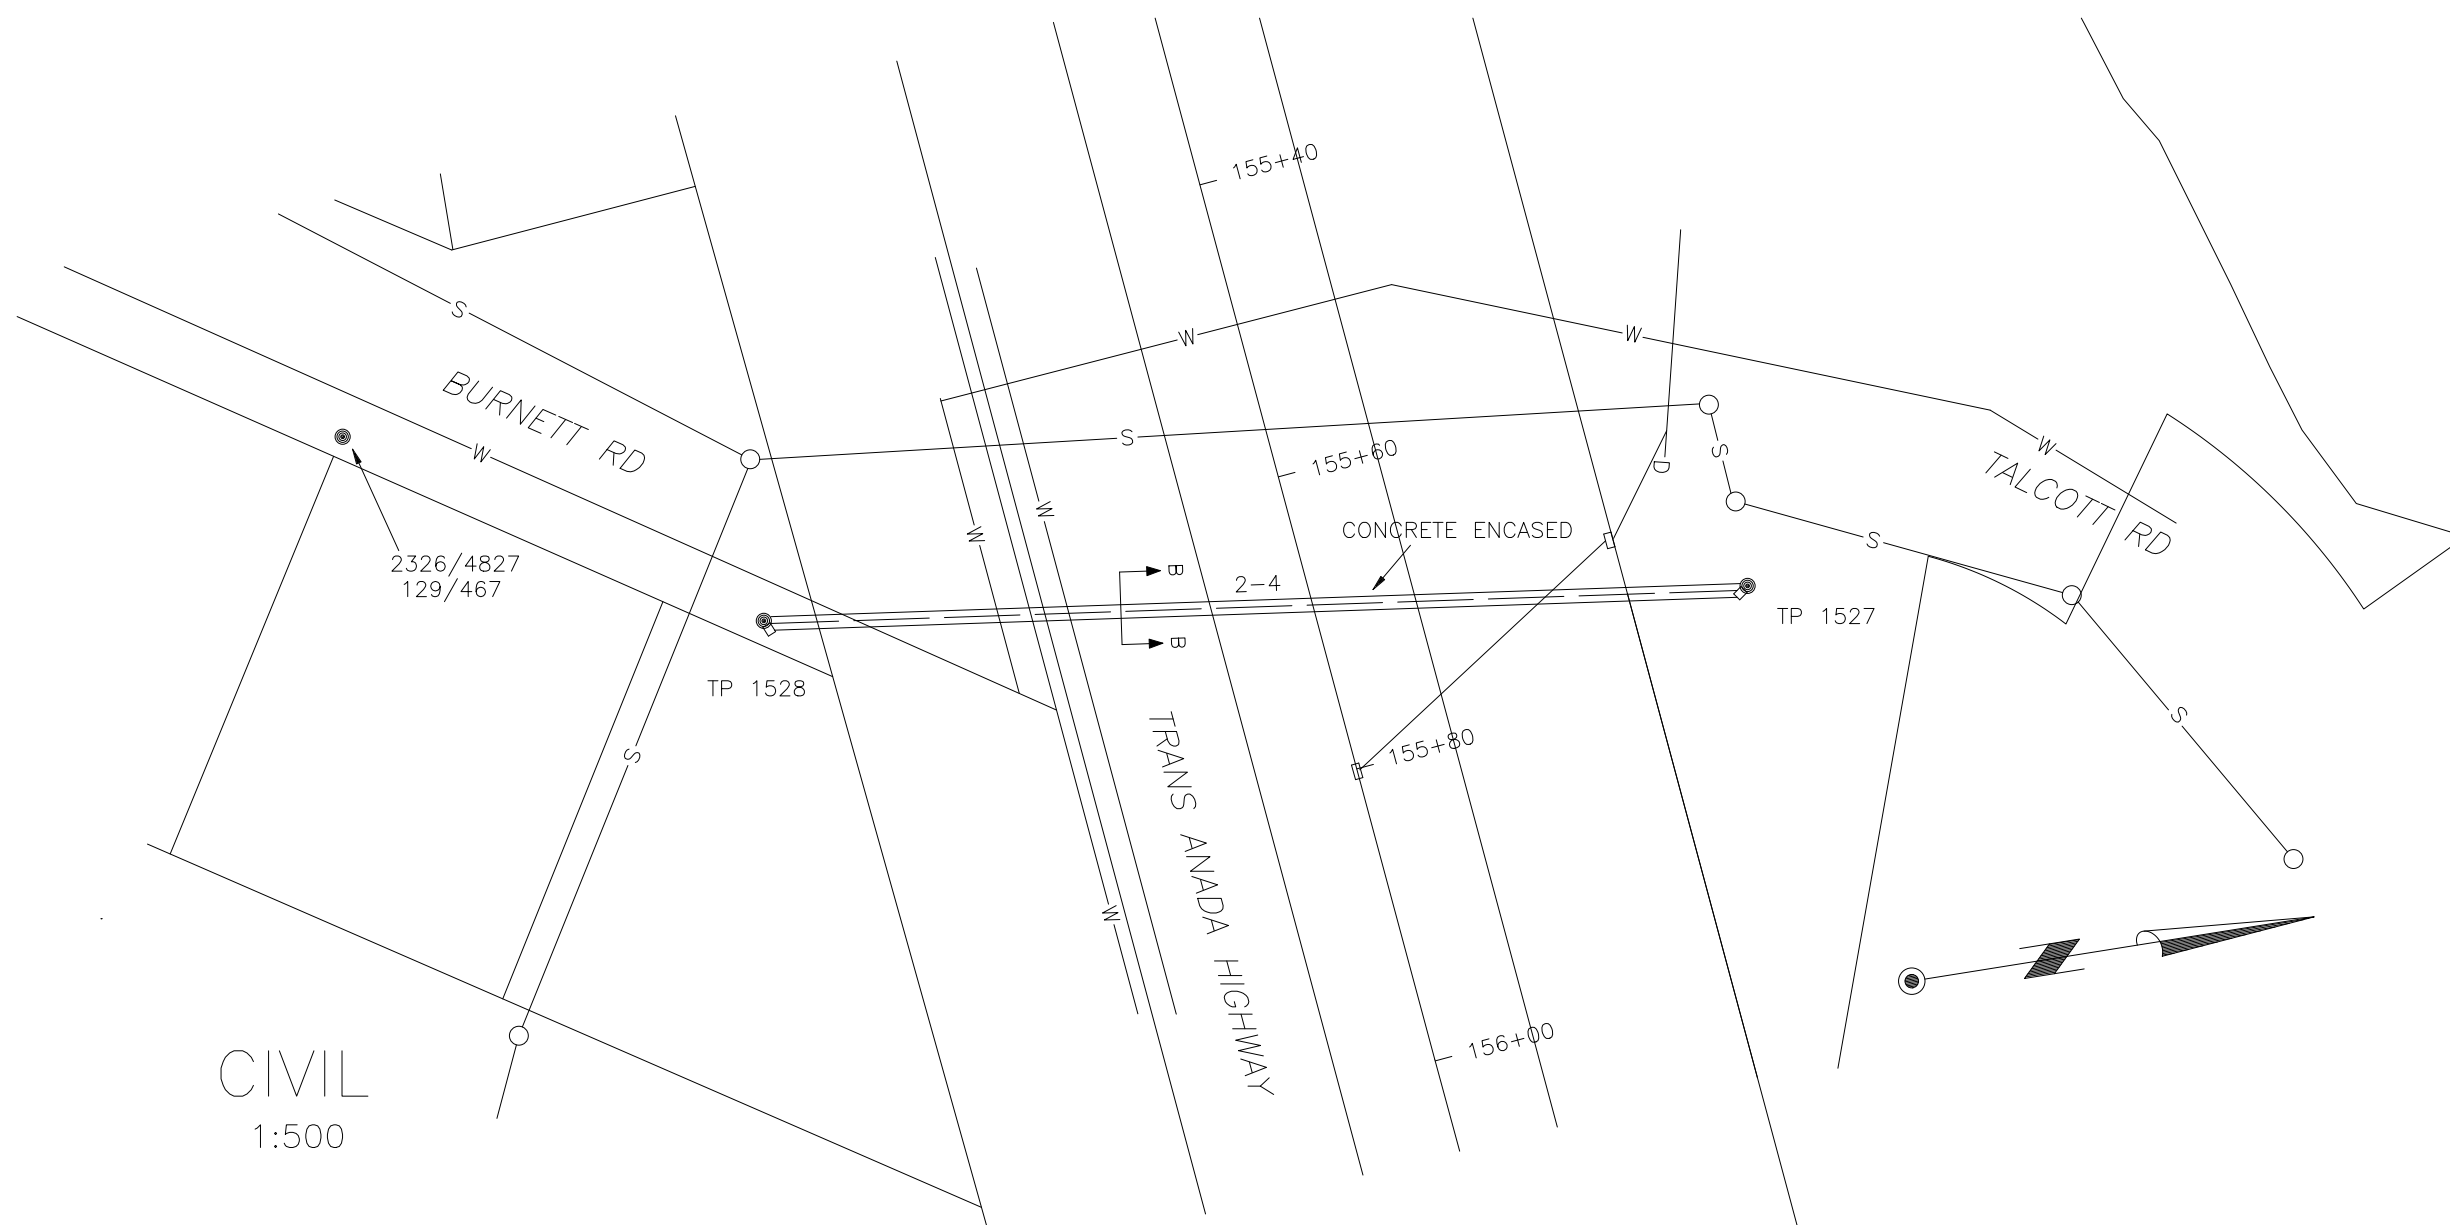

CIVIL  
1:500

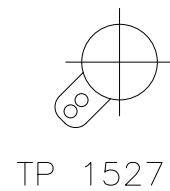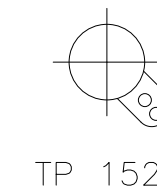

NOTE: 1m MINIMUM COVER  
NOTE: ROAD WORK BY BC HYDRO CONTRACTOR

JOB 8370-672781  
PROJ.

VICTORIA AREA  
DISTRIBUTION U/G  
DUCT INSTALLATION ACROSS THE TRANS CANADA HIGHWAY  
BETWEEN BURNETT RD AND TALCOTT RD  
VIEW ROYAL

REFERENCE DRAWINGS	REVISIONS	SCALE: 1:500	FILENAME: C4222.DWG
GFIS MAP AON5C4	1 AS CONSTRUCTED	JL	97/04/16
ES43U6.6-20 DUCT DETAILS	No. REMARKS	BY CH. APPR. DATE	DR. CH. DATE

APPROVALS	
DES. JRP	DATE 97/03/06
DES. CH.	
DR. JL	DATE 97/03/07
DR. CH.	